


1 FIRST FLOOR FURNITURE PLAN - WAREHOUSE & METER SHOP
A-900 SCALE: 1/8" = 1'-0"



KEYPLAN

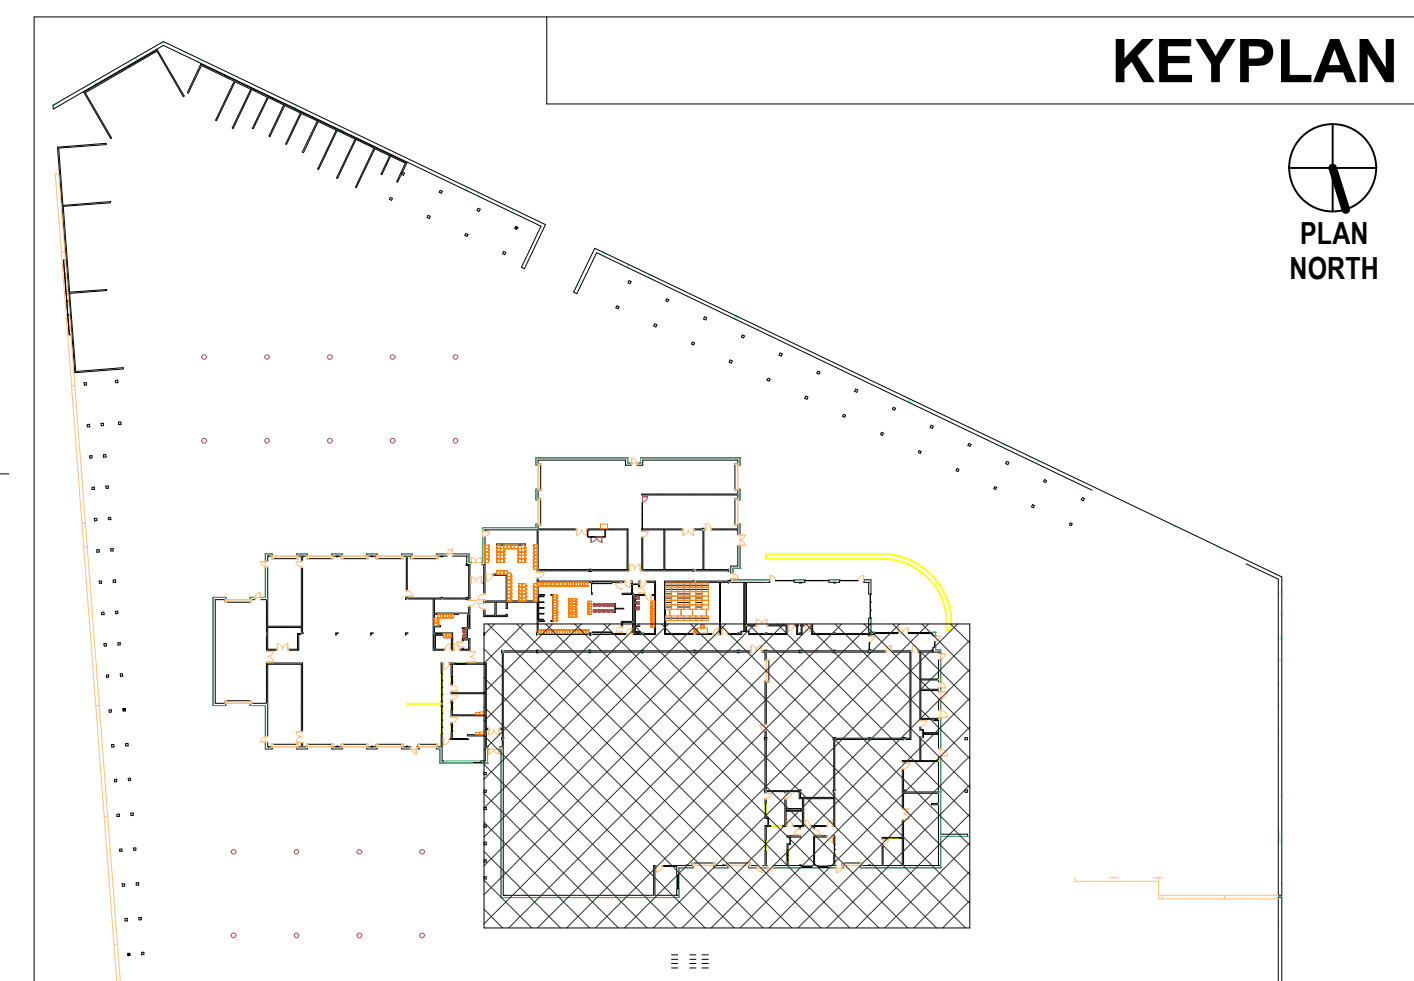


PLAN NORTH

7/17/2024 9:55:30 AM B:\360\17207-02 FCVA Willard Road Maintenance Facility\ARCH\141

REVISIONS

DATE	PROJECT	DESIGNED	DRAWN	CHECKED
5/15/2024	17207-02	GSL	HAW	DWH

RRMM
ARCHITECTS, PC
2900 South Quincy Street, Suite 710
Arlington, Virginia 22206
(703)998-0101

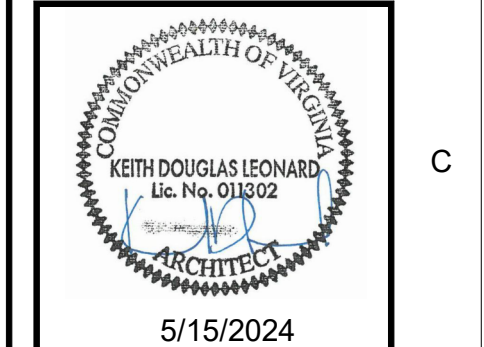

5/15/2024



FAIRFAX COUNTY WATER AUTHORITY
WILLARD ROAD MAINTENANCE FACILITY
14925 Willard Road
Chantilly, VA 20151

FURNITURE PLAN - WAREHOUSE & METER SHOP

SHEET
A-900


7/1/2024 9:55:33 AM B:\360\17207-02 FCVA Willard Road Maintenance Facility\17207-02\01 FCVA Willard Road Maintenance Facility - ARCH.rvt

1 FIRST FLOOR FURNITURE PLAN - FLEET
A-901 SCALE: 1/8" = 1'-0"

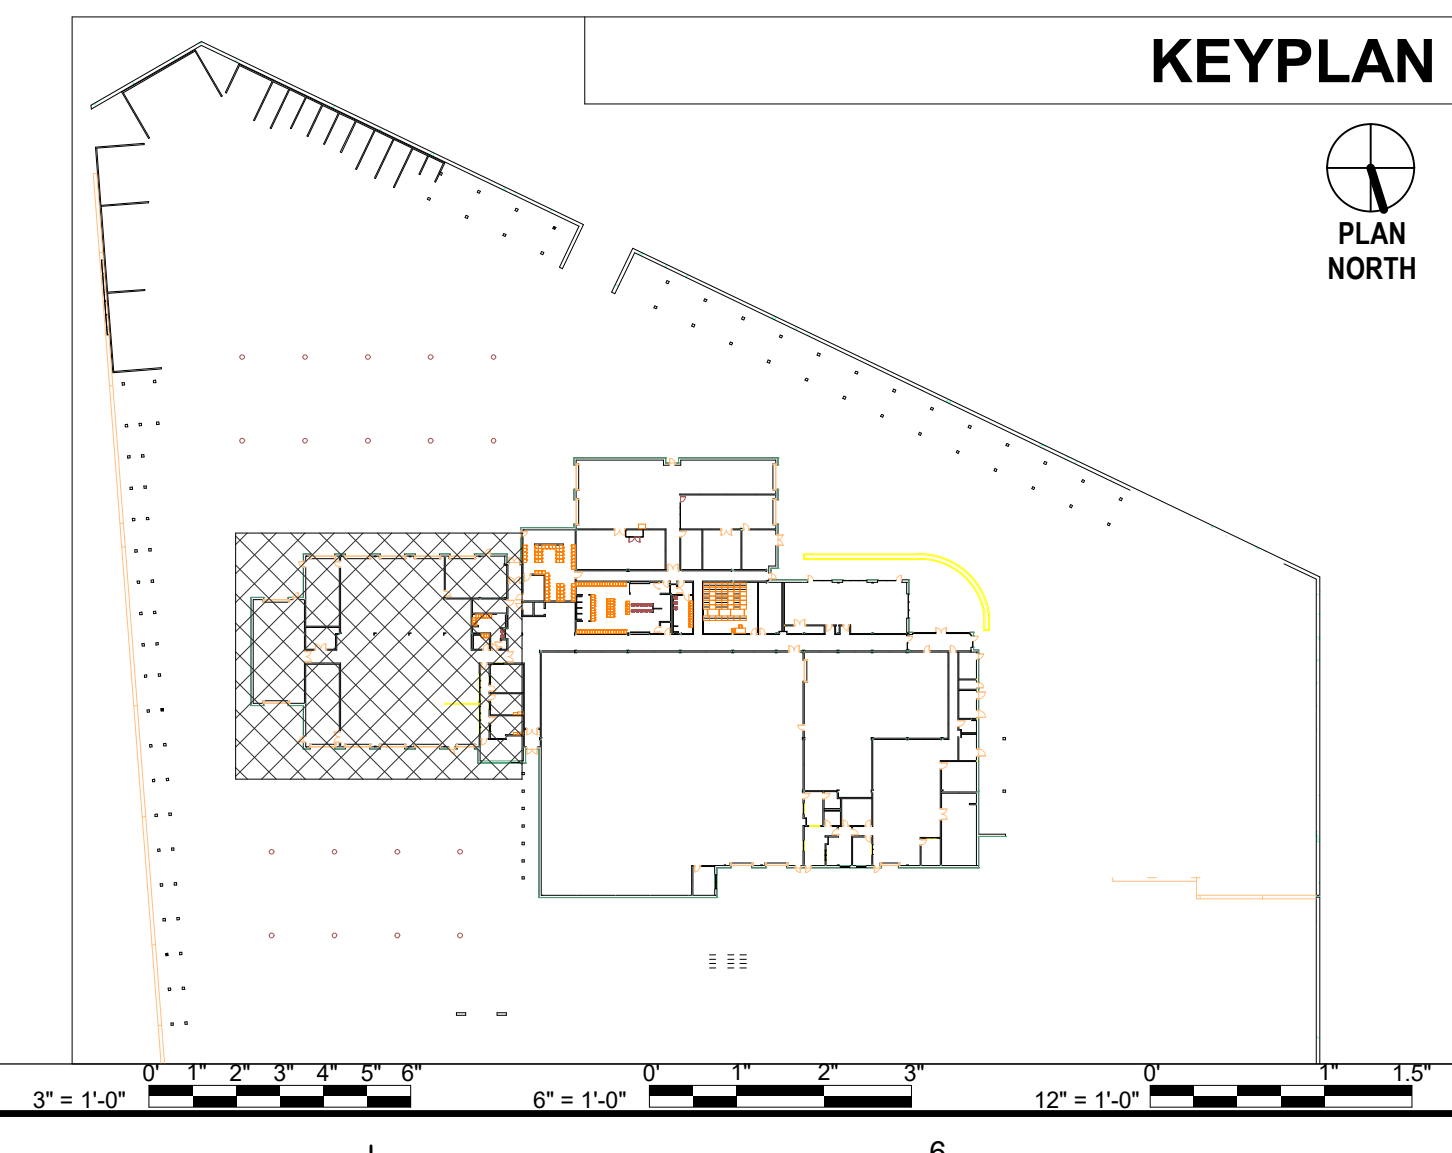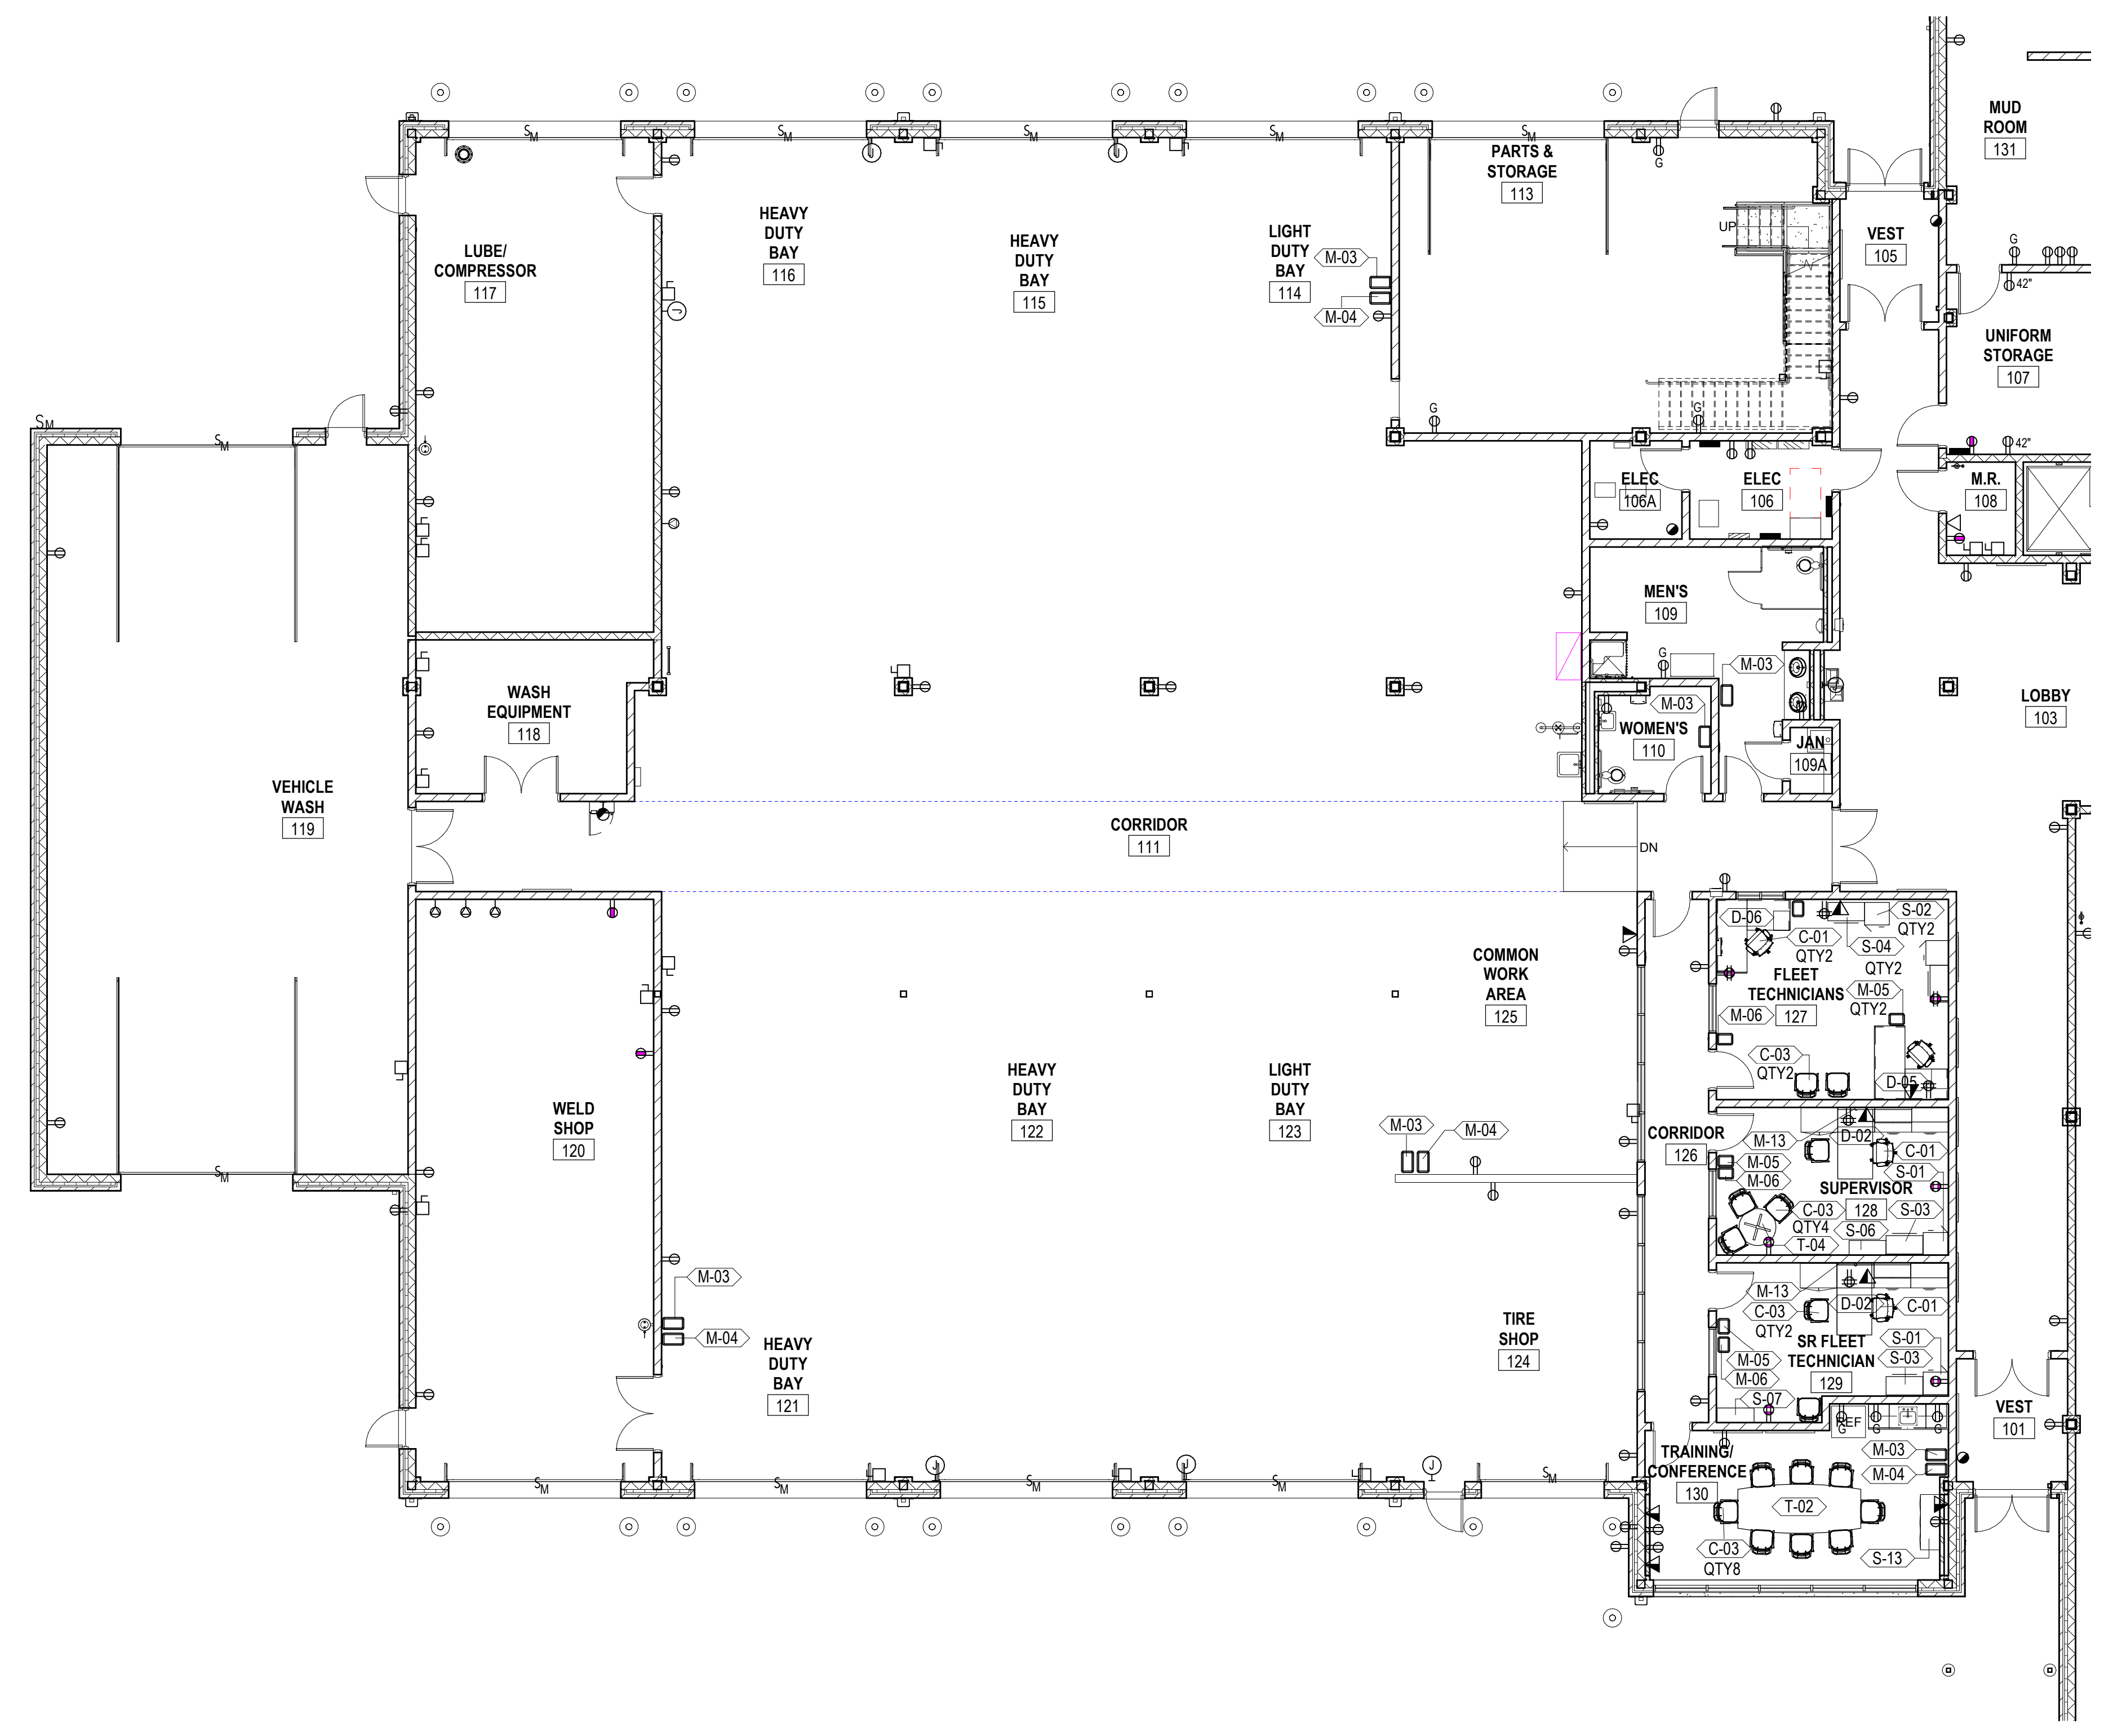


REVISIONS

DATE	9/15/2024	DESIGNED	GSL	DRAWN	HAW	CHECKED	DWH
PROJECT	17207-02						


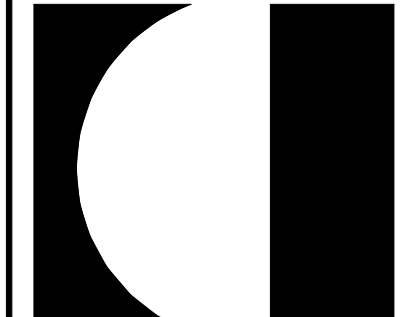


RRMM ARCHITECTS, PC
2900 South Quince Street, Suite 710
Arlington, Virginia 22206
(703)998-0101

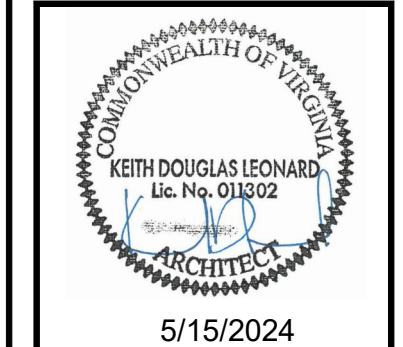


PROJECT FAIRFAX COUNTY WATER AUTHORITY
WILLARD ROAD MAINTENANCE FACILITY
14925 Willard Road
Chantilly, VA 20151
DRAWING FURNITURE PLAN - FLEET

SHEET
A-901

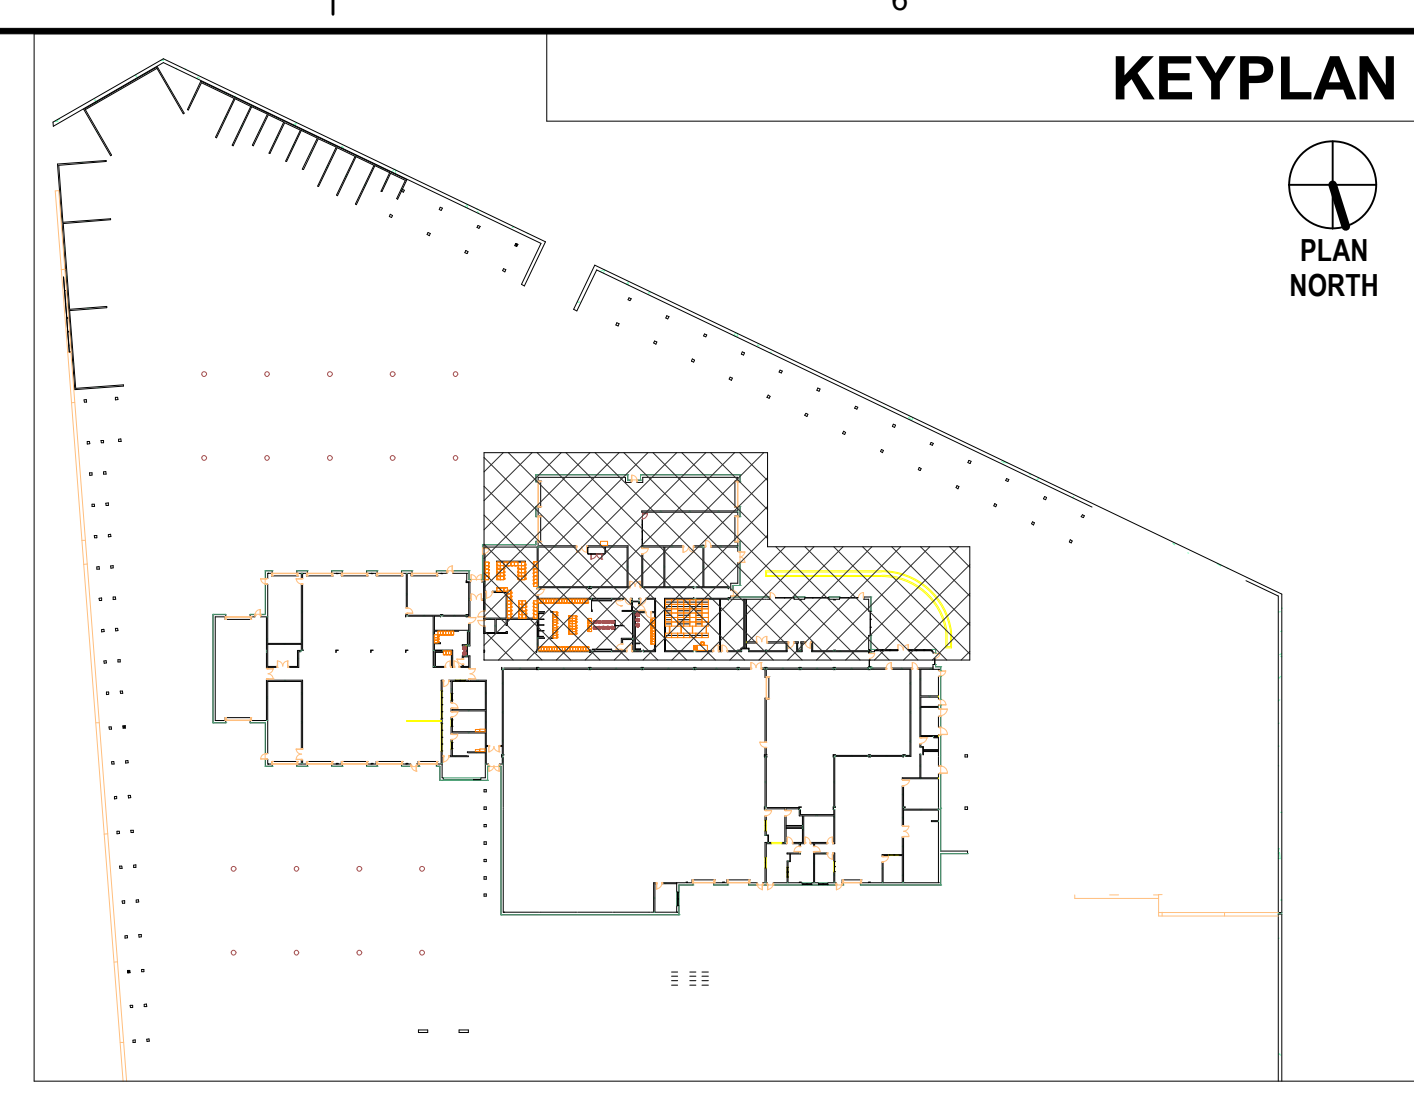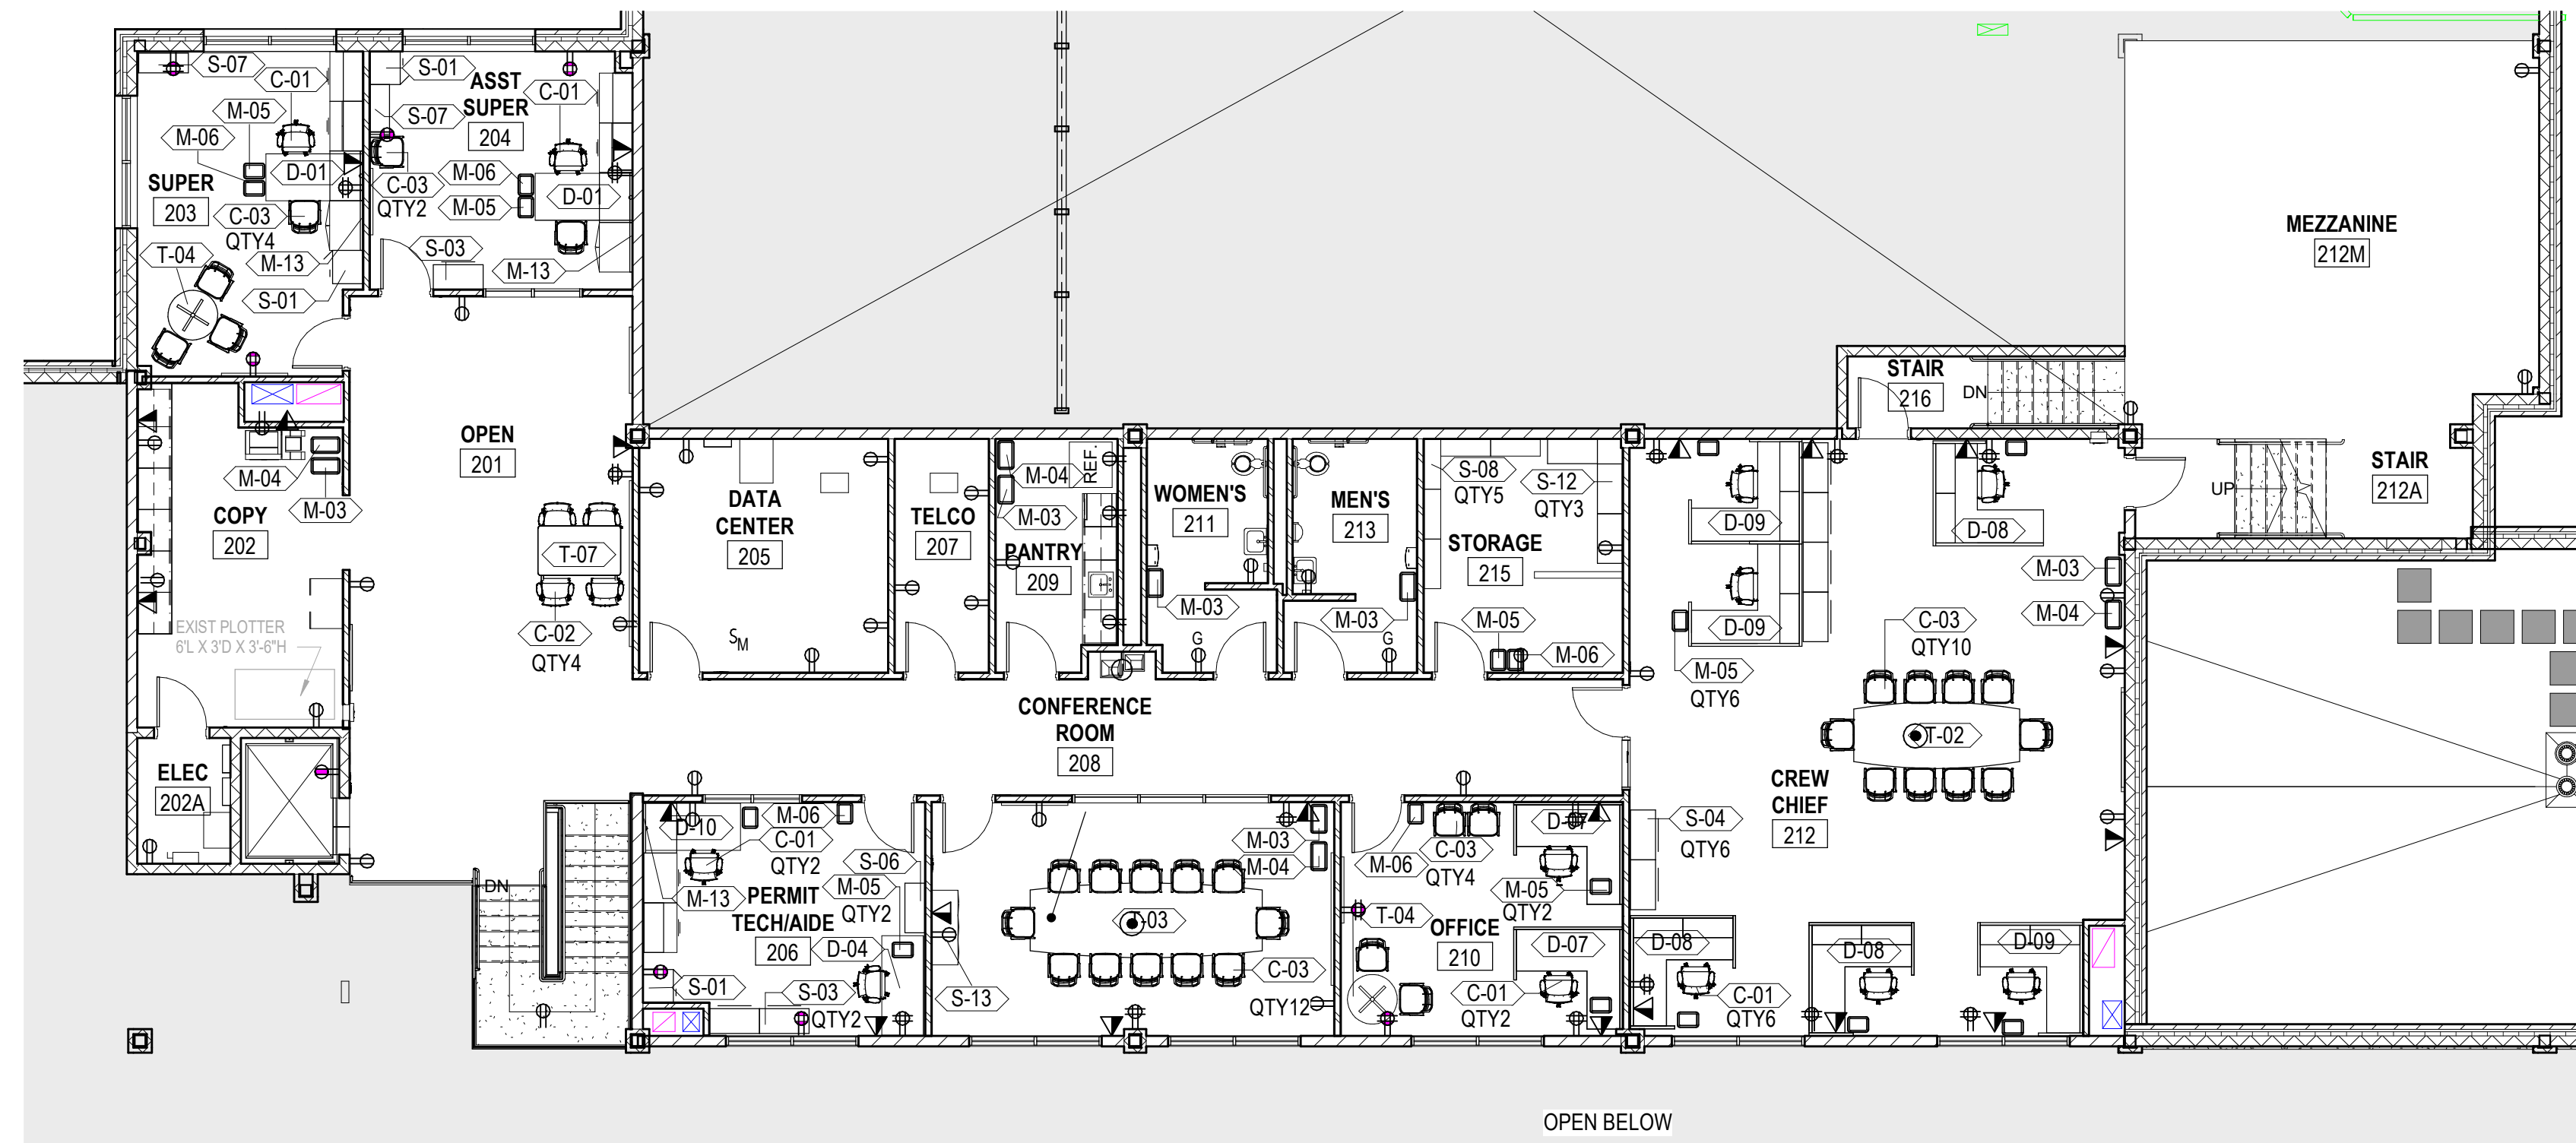

2 SECOND FLOOR PLAN - DISTRIBUTION
SCALE: 1/8" = 1'-0"

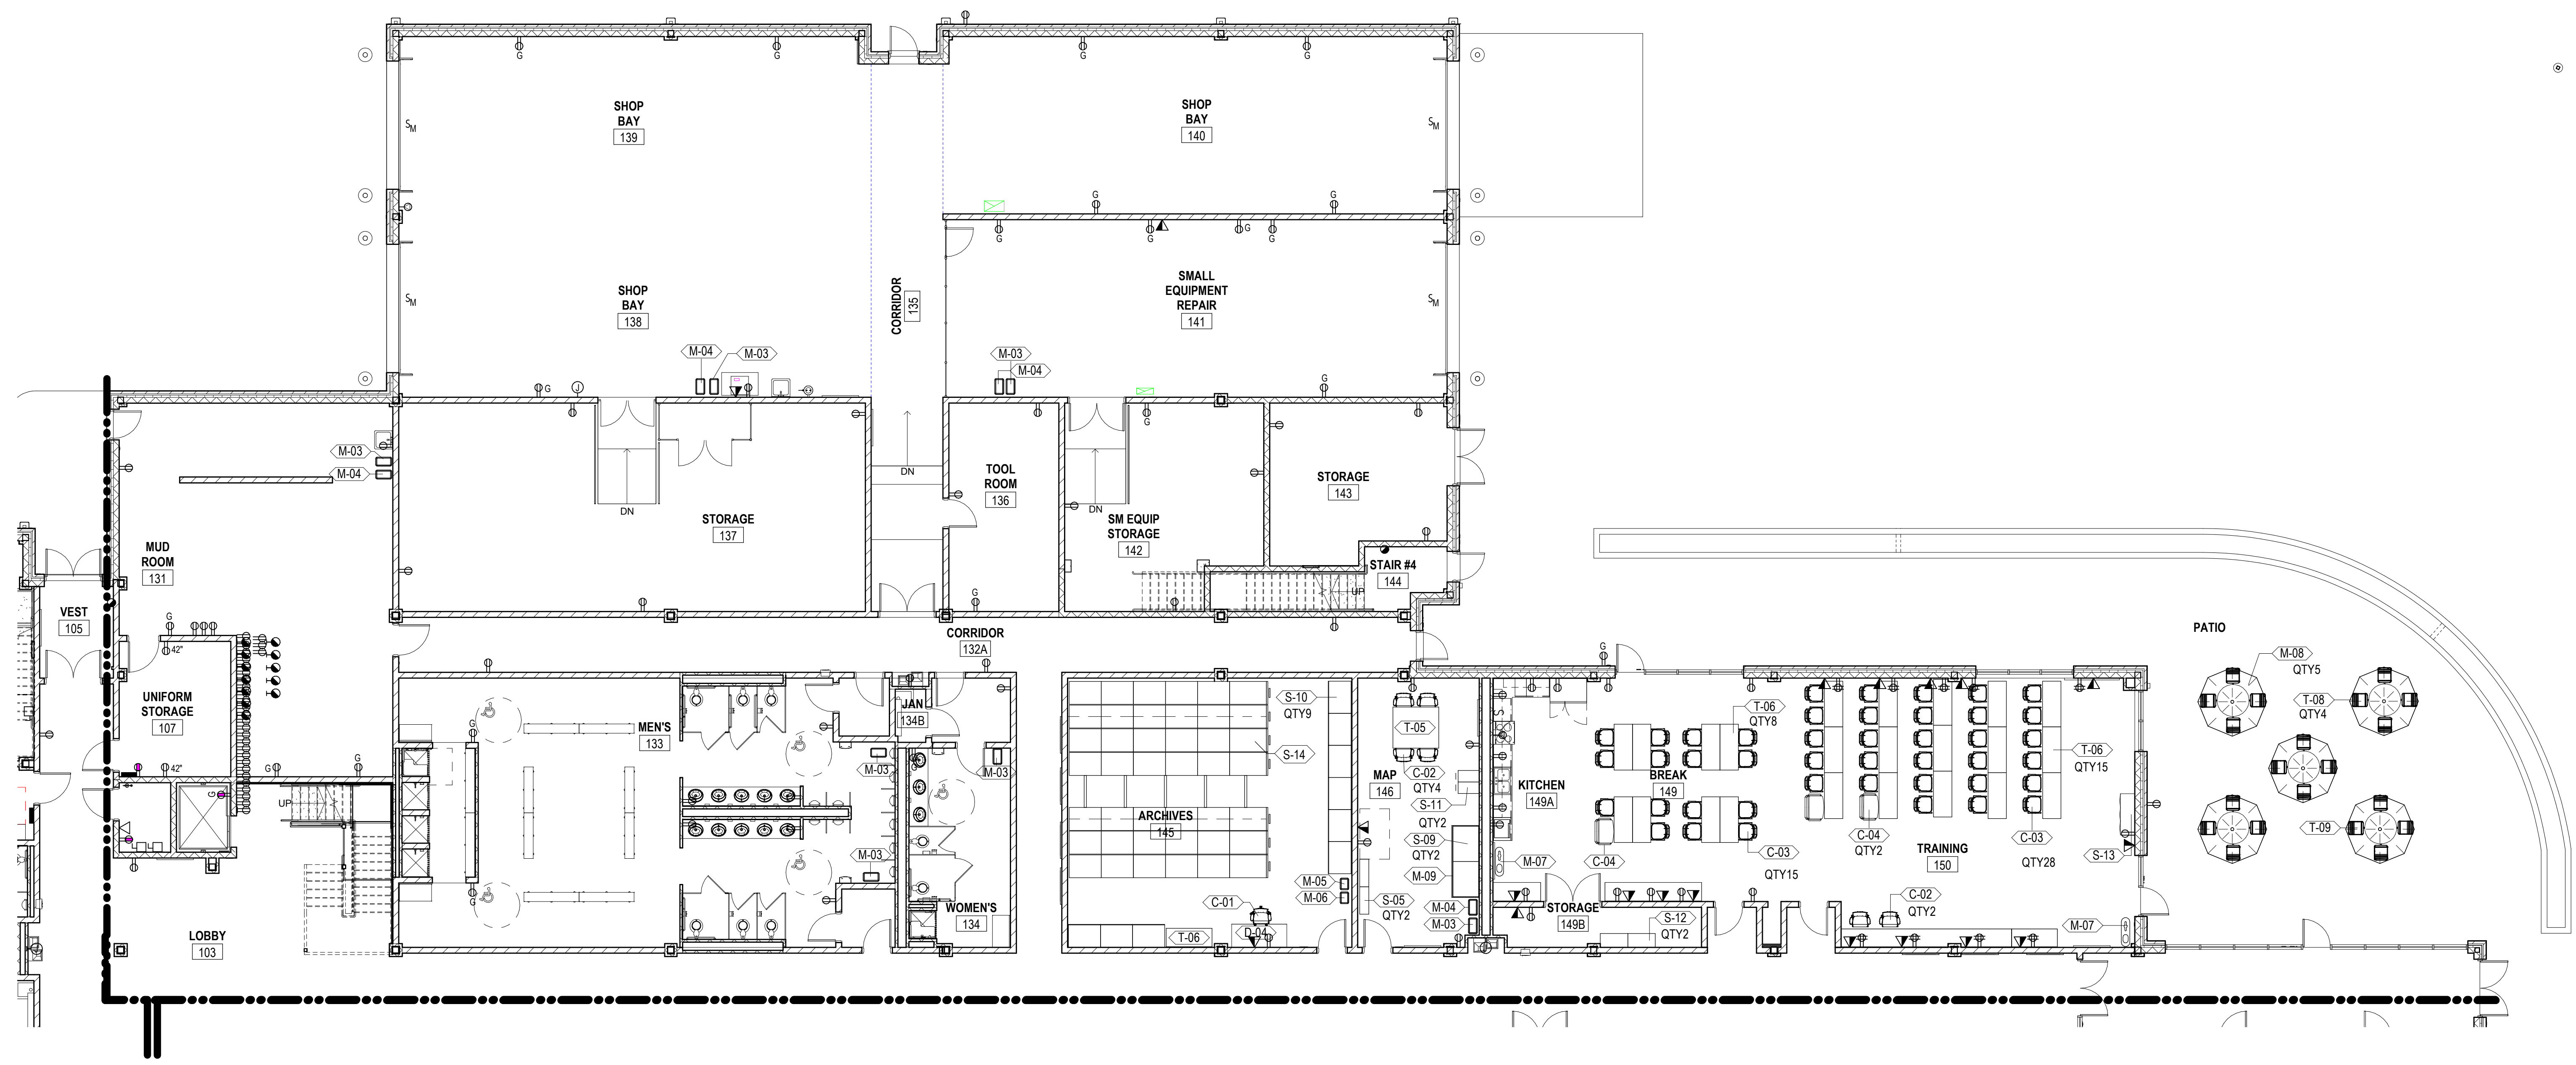


1 FIRST FLOOR FURNITURE PLAN - DISTRIBUTION
SCALE: 1/8" = 1'-0"

REVISIONS

DATE	PROJECT	DESIGNED	DRAWN	CHECKED
9/15/2024	17207-02	GSL	HAW	DWH

RRMM
ARCHITECTS, PC
2900 South Quincy Street, Suite 710
Arlington, Virginia 22206
(703)998-0101

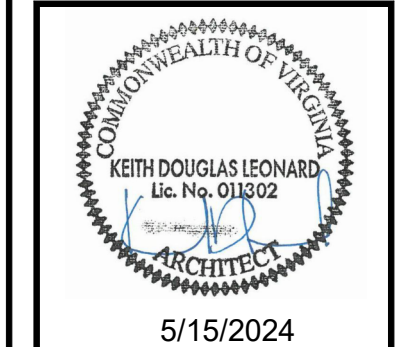

5/15/2024

PROJECT: FAIRFAX COUNTY WATER AUTHORITY
WILLARD ROAD MAINTENANCE FACILITY
14925 Willard Road
Chantilly, VA 20151
DRAWING: FURNITURE PLANS - DISTRIBUTION

SHEET
A-902

7/1/2024 9:55:45 AM B:\360\17207-02_FCAVA Willard Road Maintenance Facility - ARCH\141